

INTERIOR DECORATION WORKS OF
TANTUJA SALES EMPORIUM
AT NO. 21, LUZ CORNER, 142, R.H.
ROAD MYLAPORE, CHENNAI-600 004


ORGANIZATION :
THE WEST BENGAL STATE HANDLOOM WEAVERS' CO-OPERATIVE
SOCIETY LTD.
TANTUJA BHAVAN,BLOCK-DD, NO. 18 /4, SALT LAKE, KOLKATA - 64




- GENERAL NOTES:
- All interior works shall be executed as per approved drawings, cpwd specifications and relevant is codes.
 - Contractor shall verify all site dimensions before execution.
 - All materials shall be first quality and approved by engineer/architect.
 - Plywood shall be bwr/bwp grade conforming to is:303 / is:710.
 - Timber shall be seasoned and treated with anti-termite solution.
 - All laminates shall be minimum 1.0 mm thickness unless specified otherwise.
 - All hardware fittings shall be of approved make and quality.
 - All exposed edges of boards shall be finished with edge band / wooden lipping.
 - Electrical wiring inside furniture shall be in pvc conduit only.
 - Ceiling work shall start only after completion of concealed services.
 - Glass shall be float/toughened glass with machine polished edges.
 - All polish/paint work shall be done after proper surface preparation.
 - Contractor shall protect finished surfaces and repair any damages.
 - Finished work shall be handed over clean, complete, and as per approved samples.
 - Partition walls = 125 &75 m.m. thk. (unless & otherwise mentioned)
 - All external plaster 20 mm thk(1:6)
 - All internal plaster 13 mm thk(1:6)
 - All ceiling plaster 10 mm thk(1:4)
 - Flooring = terrazzo / i.p.s / marble / ceramic tiles
 - R.C.C. = with cement, sand and stone chips (1:2:4), (1:1.5:3), (1:1:2)
 - P.C.C. = plain cement concrete with stone chips (1:3:6), (1:4:8)
 - Steel = Fe 500

DRAWING TITLE :
FLOOR LAYOUT PLAN AND ELECTRICAL
LAYOUT PLAN.

Issue Date: 02-06-2026
Drawn By: M.A. Checked By: P.S.
PROJECT No: 402 SCALE:1:100
DRAWING No.: CHENNAI / 402 / 01

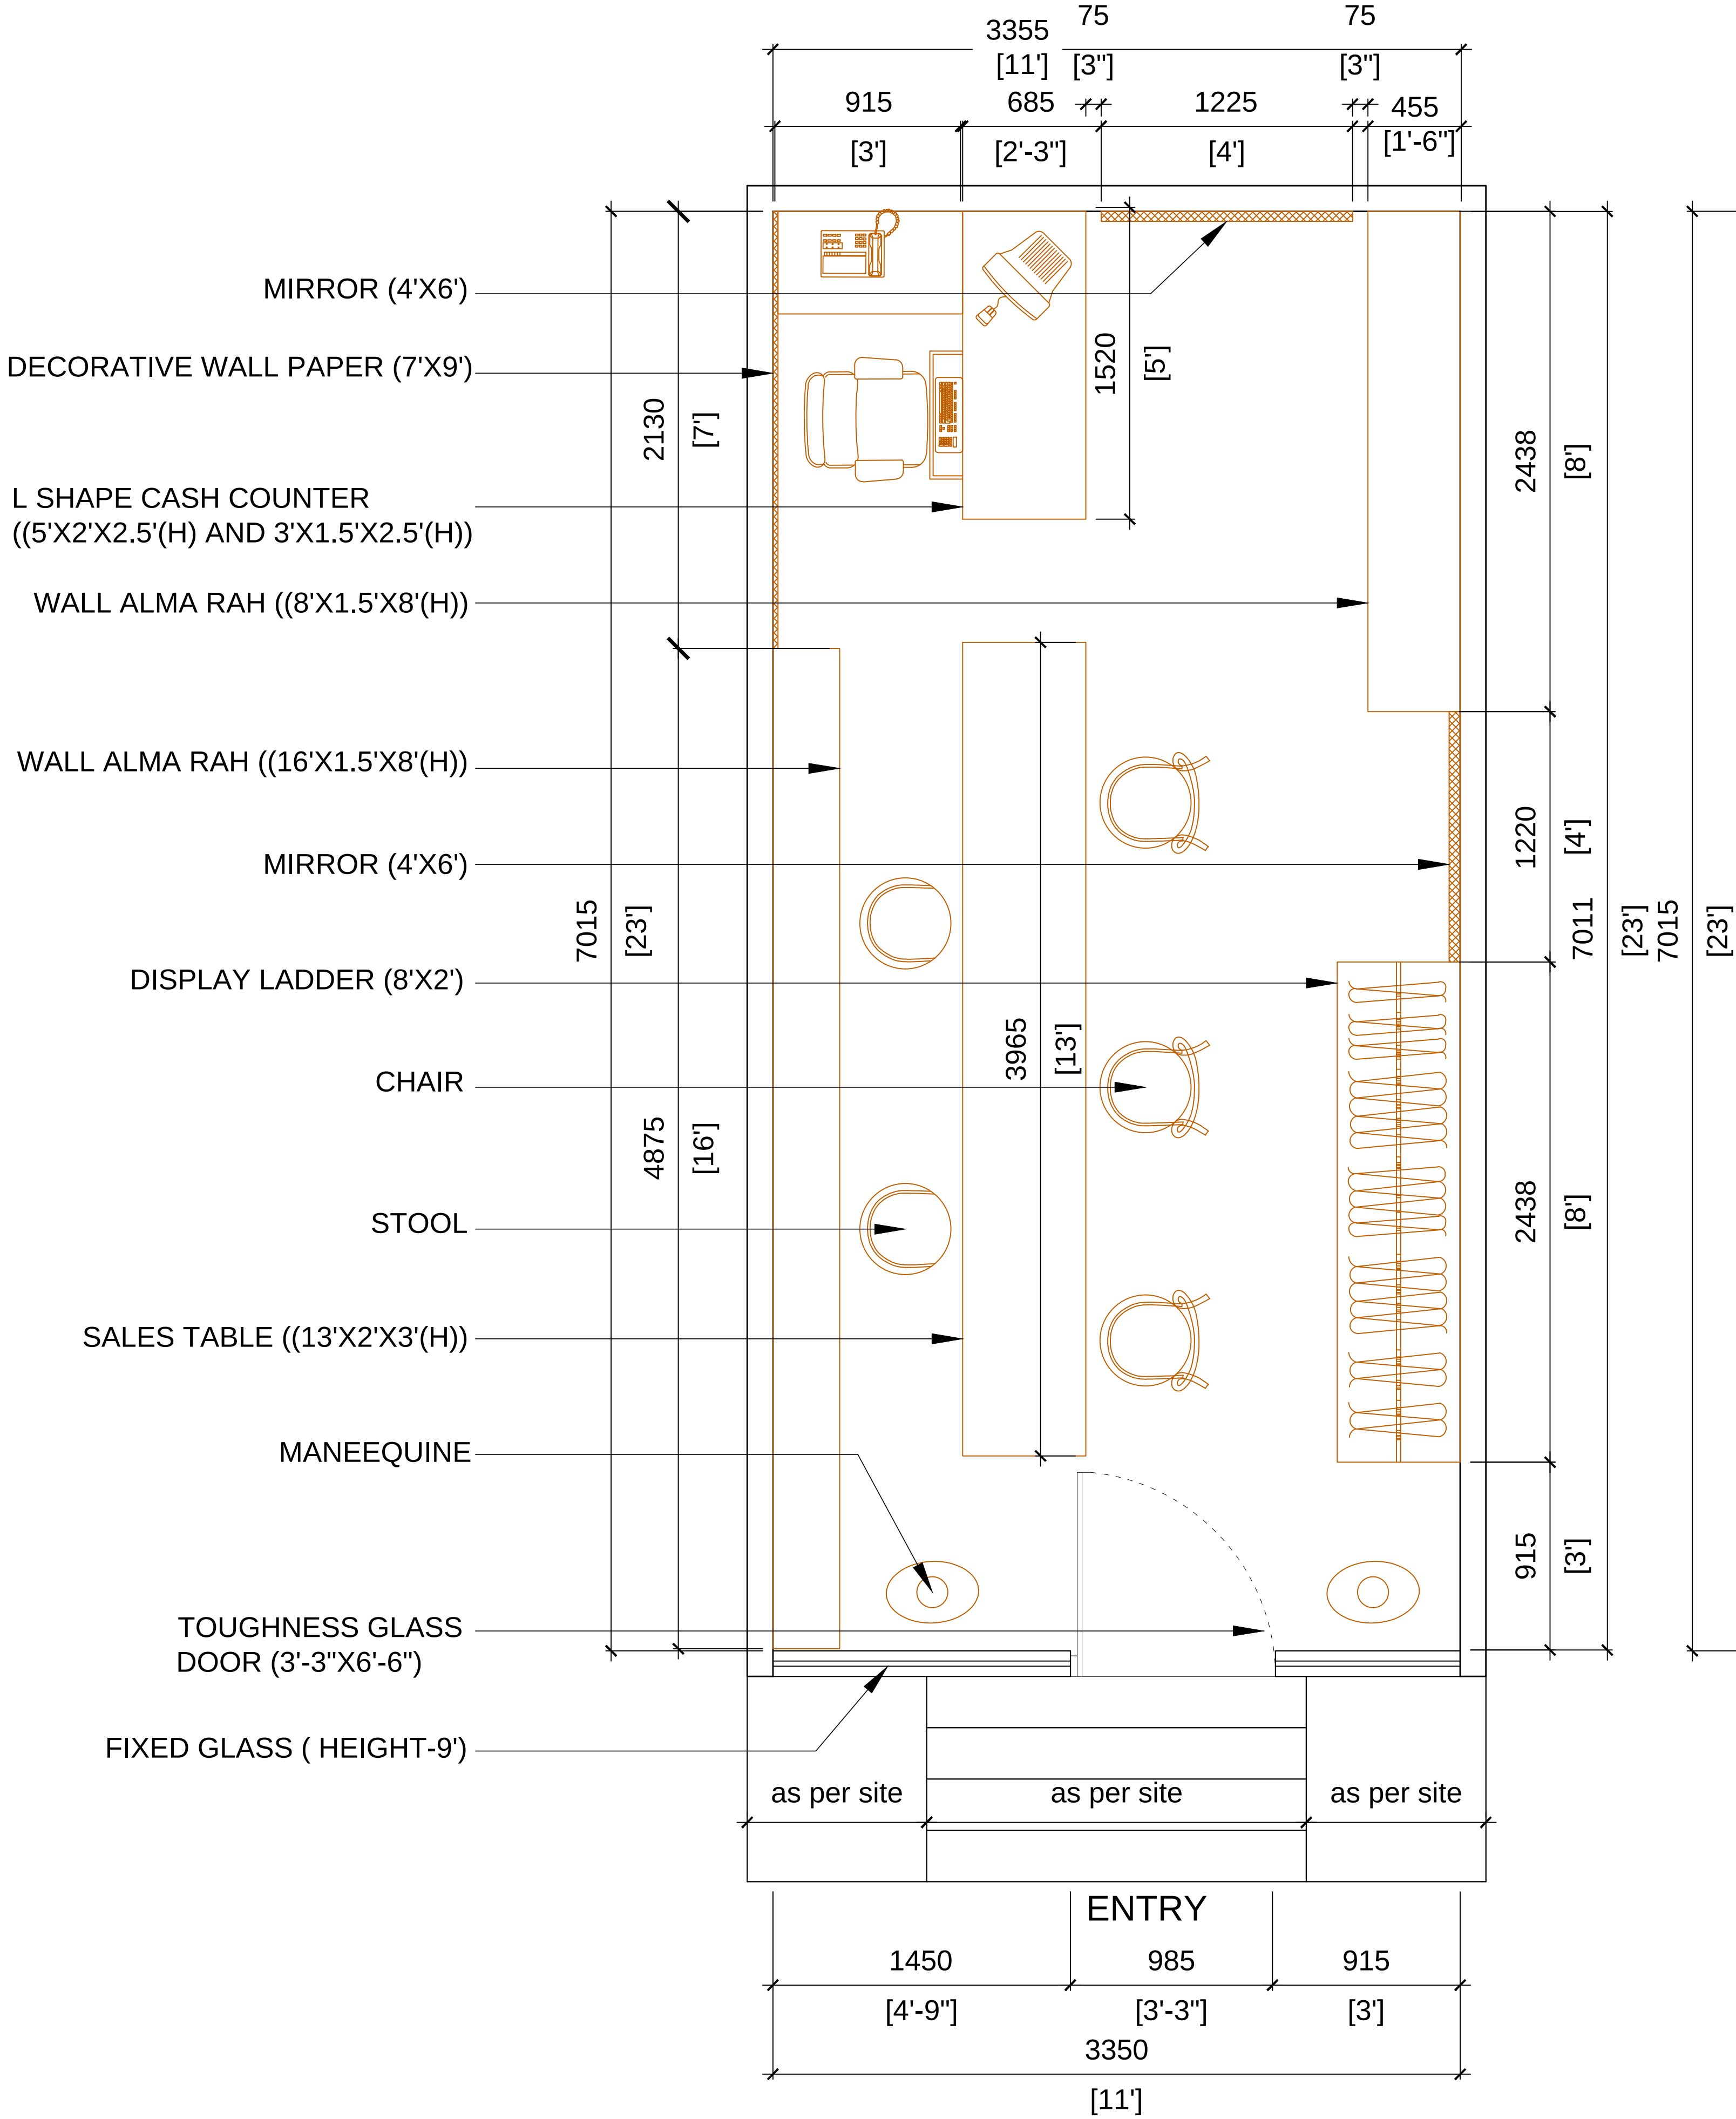

FLOOR LAYOUT PLAN

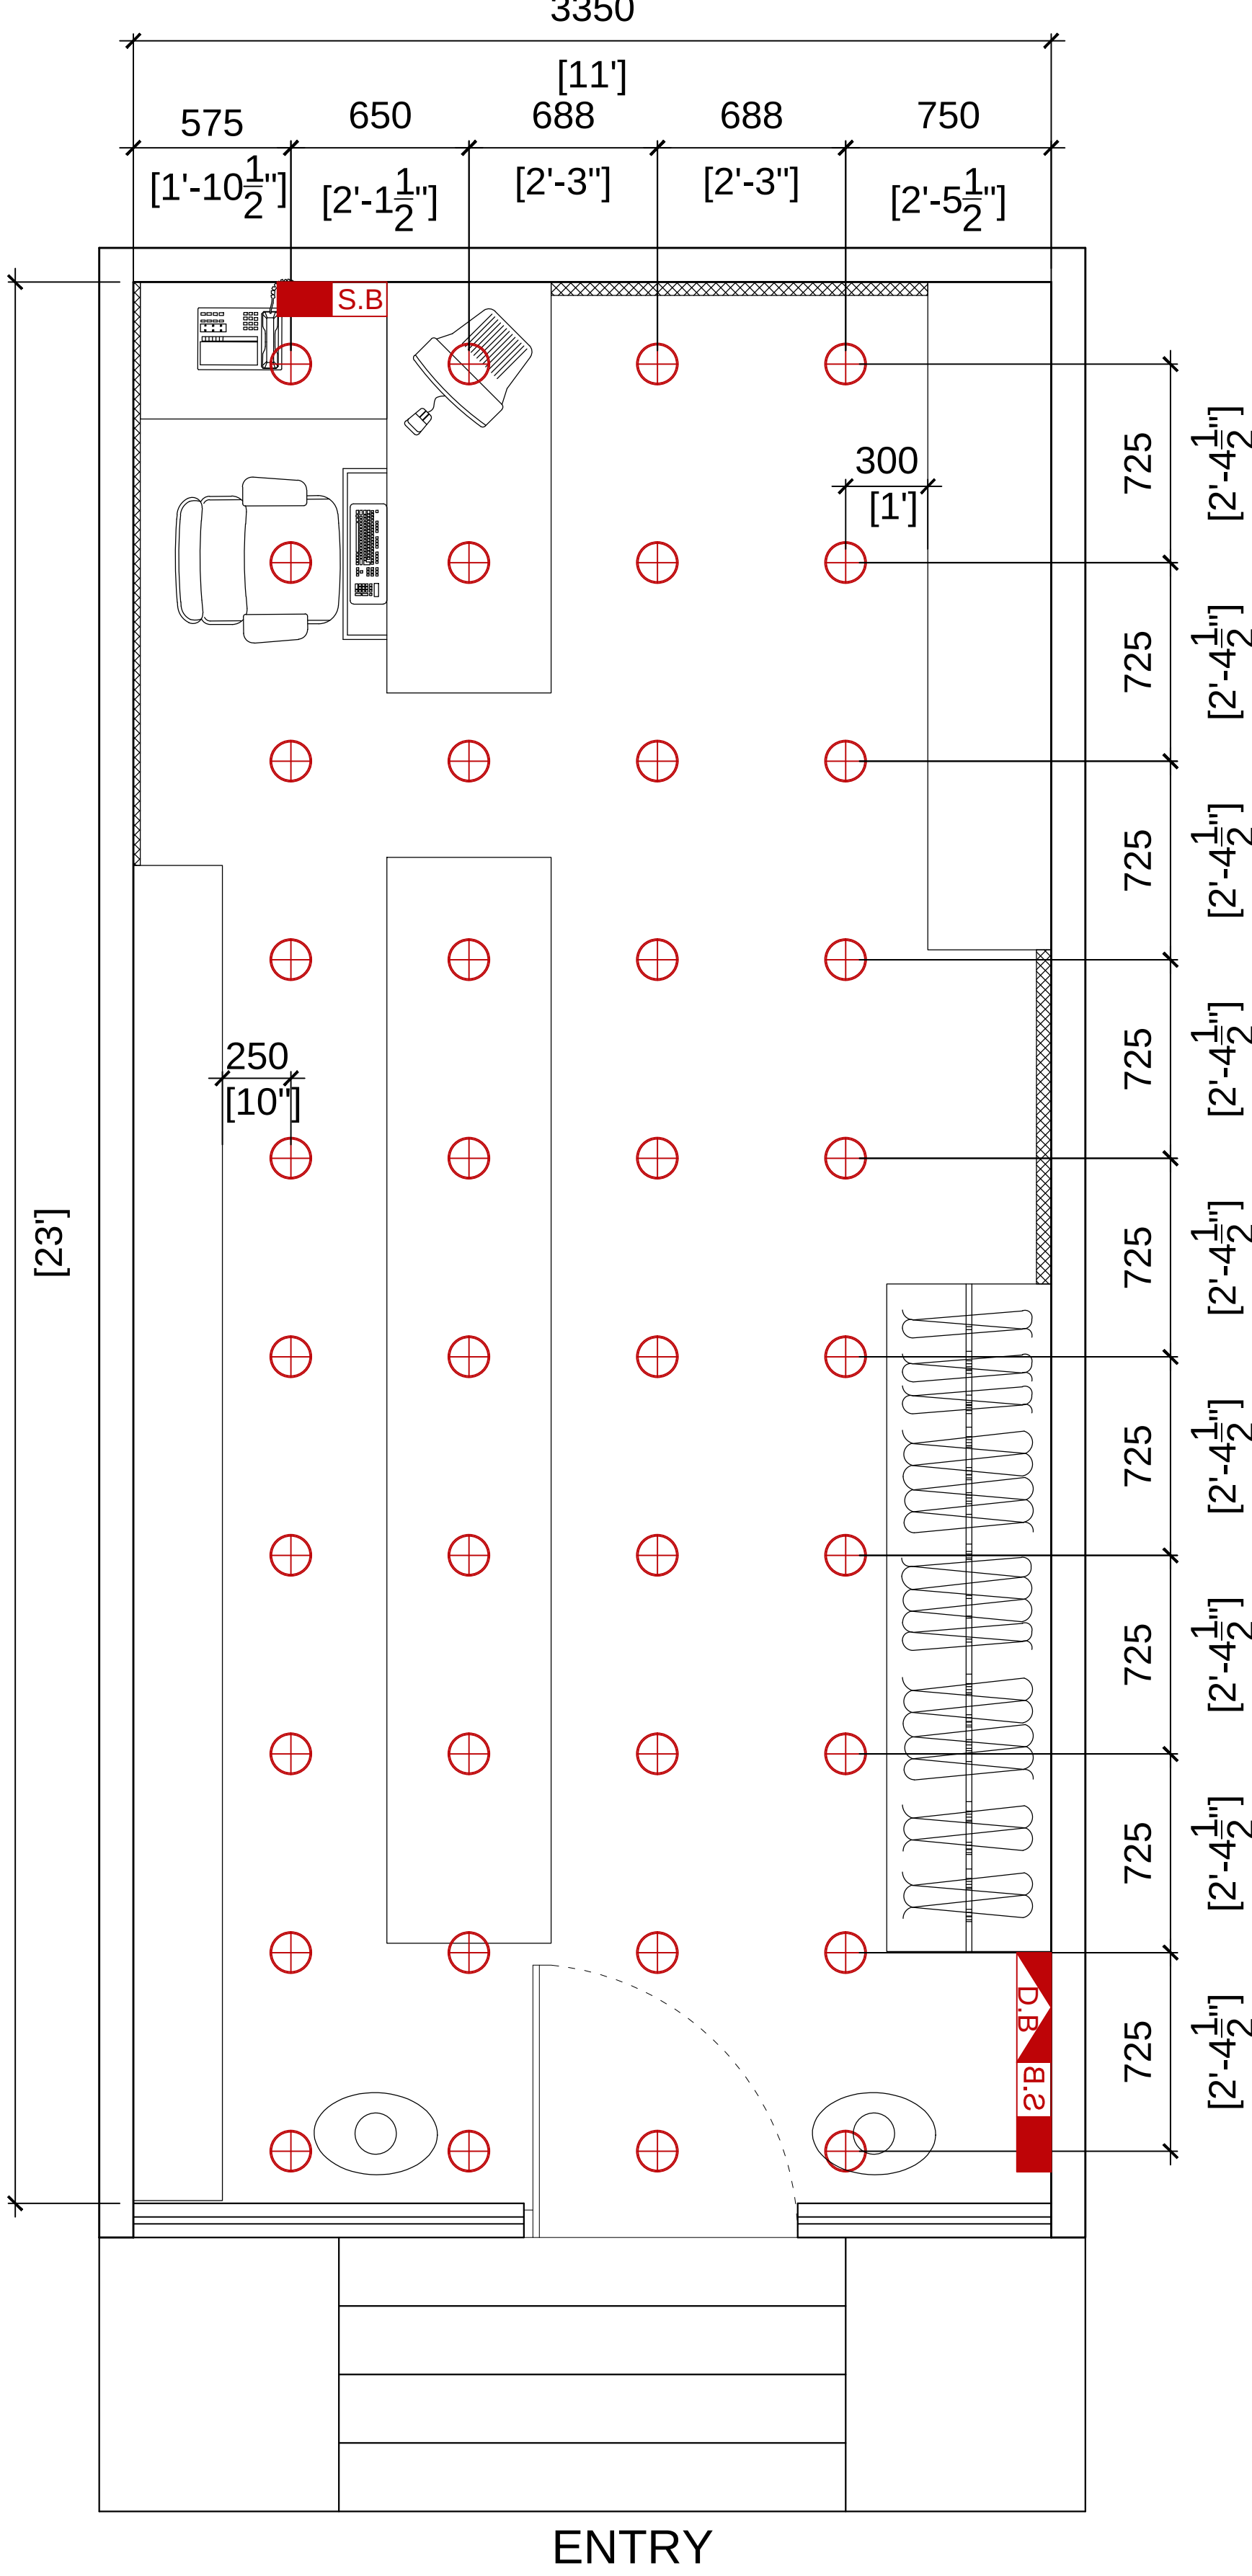

ELECTRICAL LAYOUT PLAN