

INTERIOR DECORATION WORKS OF
TANTUJA SALES EMPORIUM, JHARGRAM
BRANCH AT RAGHUNATHPUR,
P.O – JHARGRAM,
DIST – PASCHIM MEDINIPUR, PIN – 721507

ORGANIZATION :

THE WEST BENGAL STATE HANDLOOM WEAVERS' CO-OPERATIVE
SOCIETY LTD.
TANTUJA BHAVAN,BLOCK-DD, NO. 18 /4, SALT LAKE, KOLKATA - 64



ELECTRICAL SUPERVISOR

S.A.E. (CIVIL)

MANAGER (CIVIL)

GENERAL NOTES:

- All interior works shall be executed as per approved drawings, cpwd specifications and relevant is codes.
- Contractor shall verify all site dimensions before execution.
- All materials shall be first quality and approved by engineer/architect.
- Plywood shall be bwr/bwp grade conforming to is:303 / is:710.
- Timber shall be seasoned and treated with anti-termite solution.
- All laminates shall be minimum 1.0 mm thickness unless specified otherwise.
- All hardware fittings shall be of approved make and quality.
- All exposed edges of boards shall be finished with edge band / wooden lipping.
- Electrical wiring inside furniture shall be in pvc conduit only.
- Ceiling work shall start only after completion of concealed services.
- Glass shall be float/toughened glass with machine polished edges.
- All polish/paint work shall be done after proper surface preparation.
- Contractor shall protect finished surfaces and repair any damages.
- Finished work shall be handed over clean, complete, and as per approved samples.
- Partition walls = 125 & 75 m.m. thk. (unless & otherwise mentioned)
- All external plaster 20 mm thk(1:6)
- All internal plaster 15 mm thk(1:6)
- All ceiling plaster 10 mm thk(1:4)
- Flooring = terrazzo / i.p.s / marble / ceramic tiles
- R.C.C. = with cement, sand and stone chips (1:2:4), (1:1.5:3), (1:1:2)
- P.C.C. = plain cement concrete with stone chips (1:3:6), (1:4:8)
- Steel = Fe 500

DRAWING TITLE :

FLOOR LAYOUT PLAN AND ELECTRICAL
LAYOUT PLAN.

Issue Date: 27-03-2026


Drawn By: M.A.

Checked By: P.S.


PROJECT No: 1624-I

SCALE:1:100

DRAWING No.: JHARGRAM / 1624-I / 01

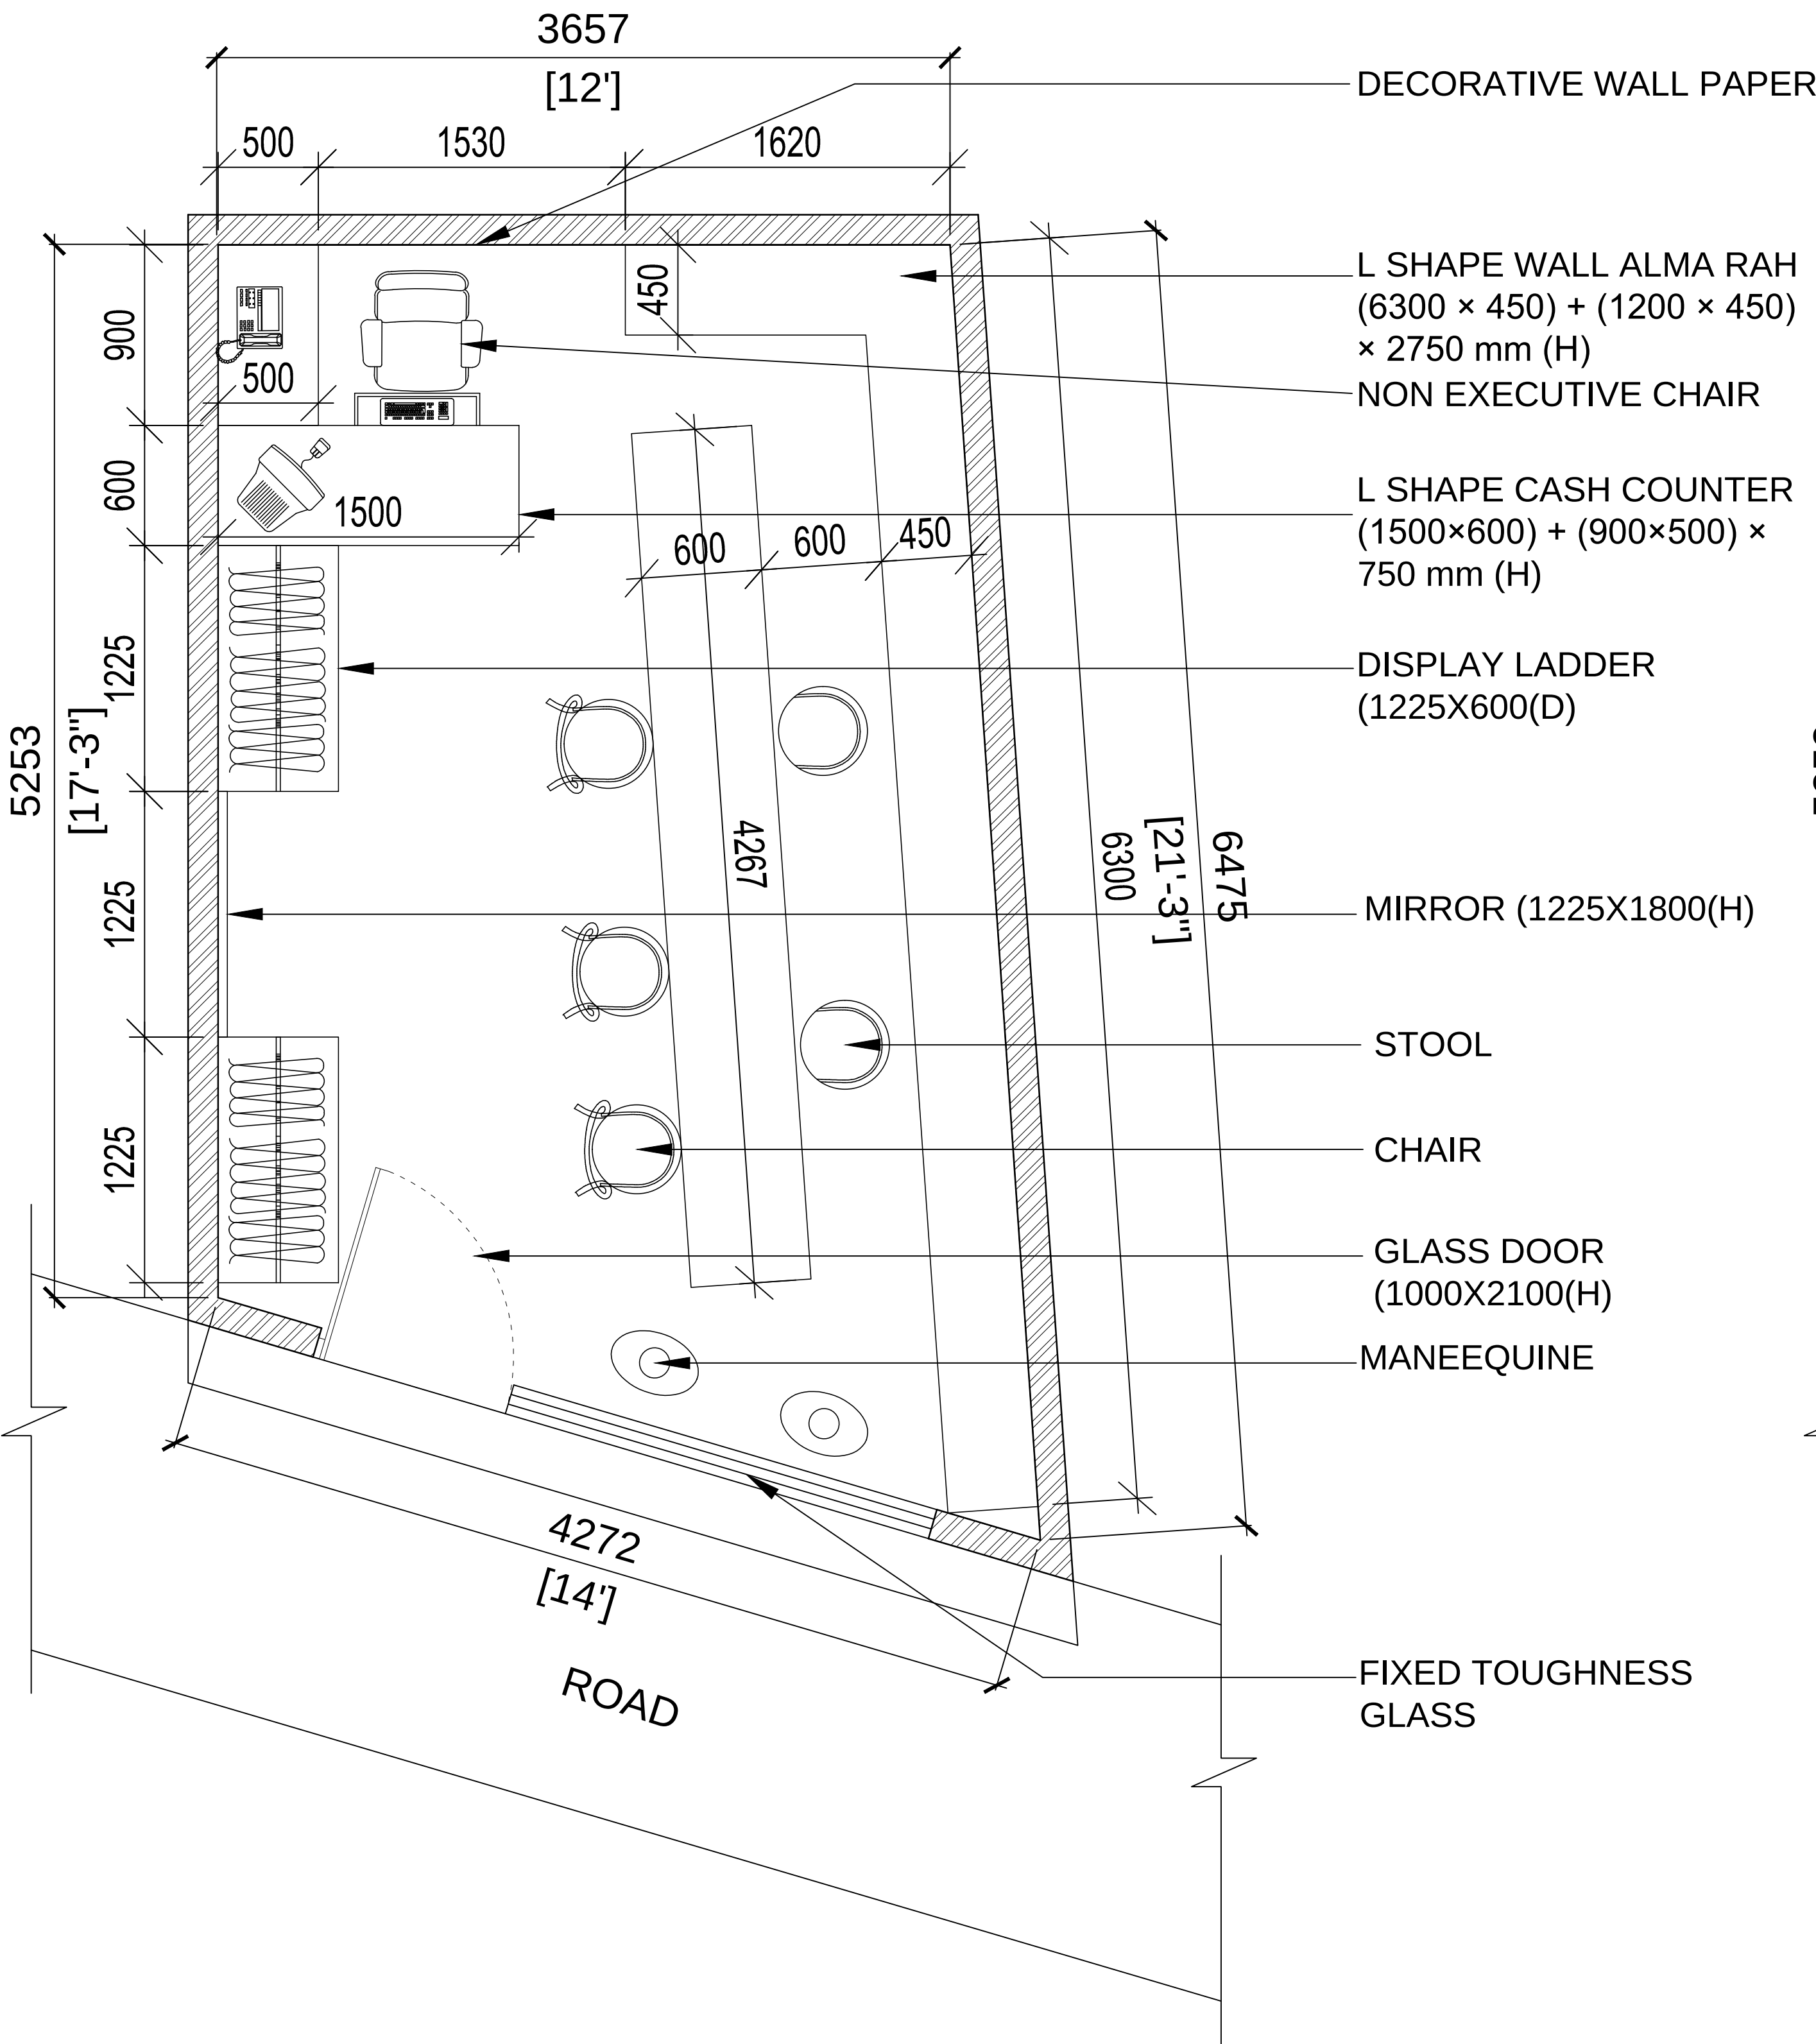

FLOOR LAYOUT PLAN

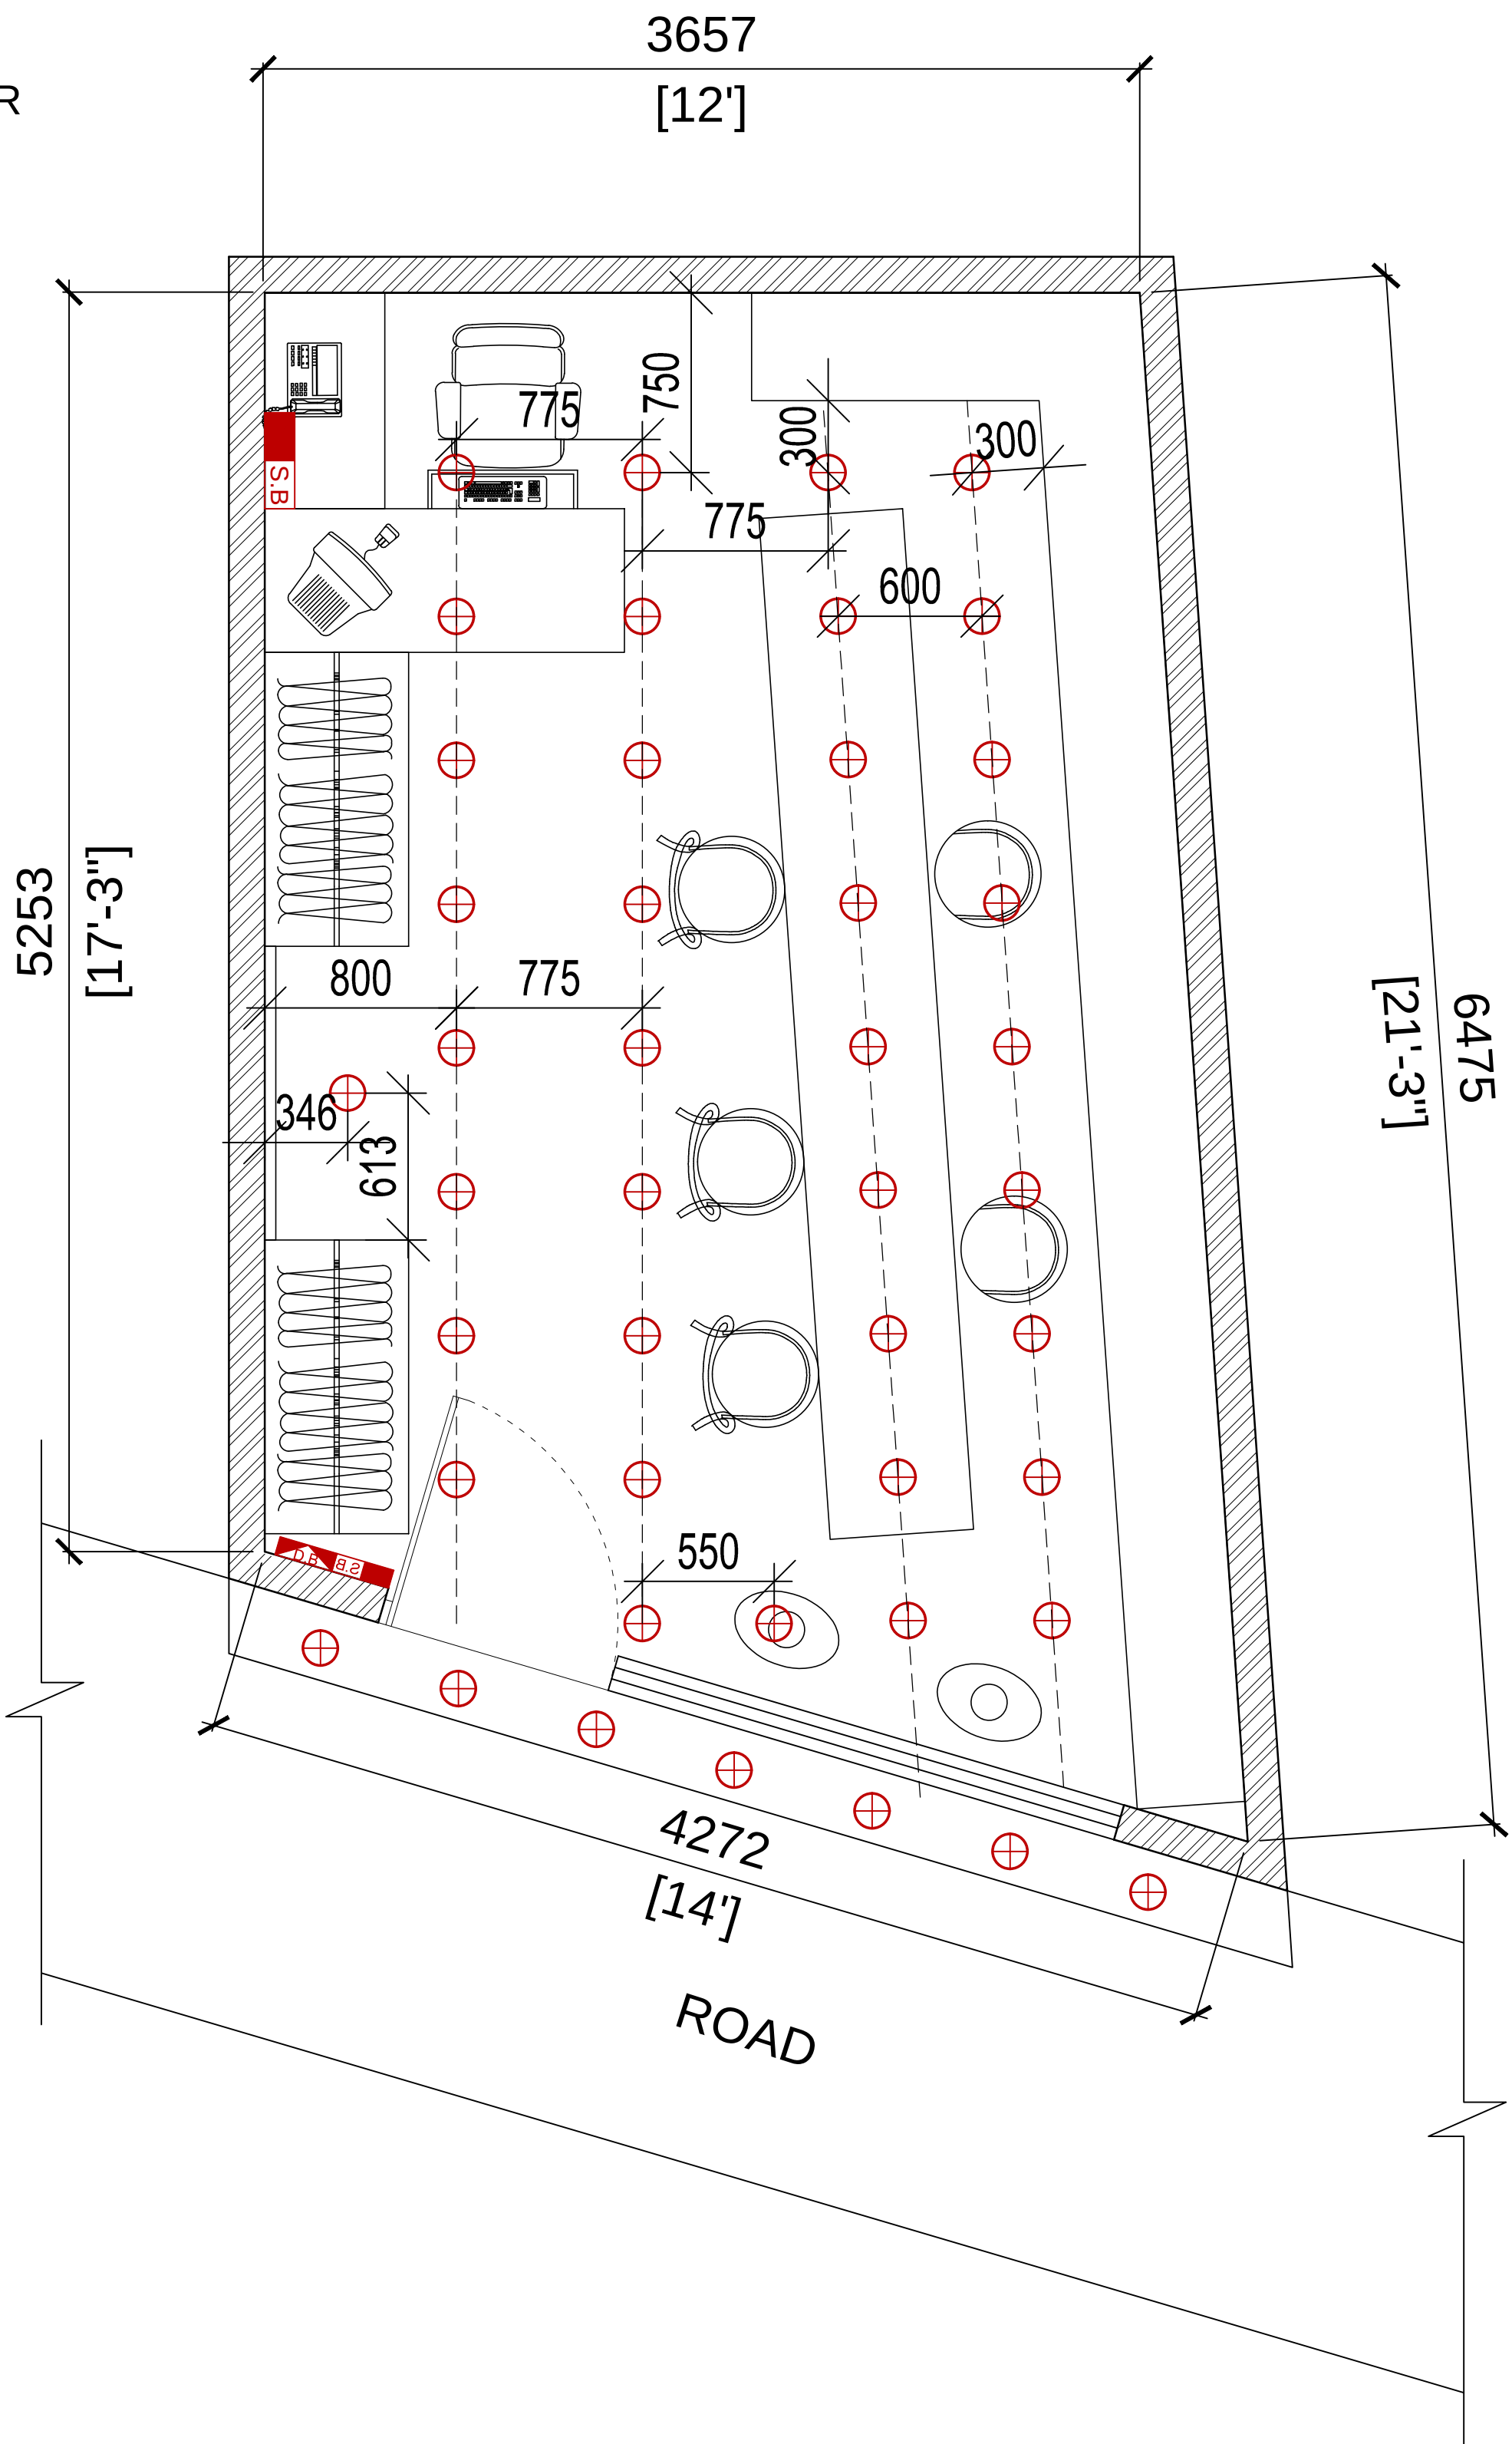

ELECTRICAL LAYOUT PLAN